


PIPING FLOOR PLAN
1/4" = 1'-0"

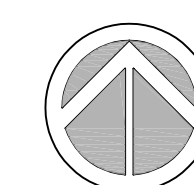


KEY PLAN
NOT TO SCALE

SHEET GENERAL NOTES

- SEE APPLICABLE NOTES ON SHEET H001.
- KITCHEN EQUIPMENT FURNISHED BY OWNER UNLESS OTHERWISE NOTED. SEE ARCHITECTURAL DRAWINGS FOR ADDITIONAL INFORMATION.
- CEILING SPACES ABOVE OFFICE AREAS TO BE USED AS A RETURN AIR PLENUM.

KEY NOTES

- 1" LP DOWN TO WATER HEATER (199 MBH INPUT). COORDINATE LOCATION AND FINAL CONNECTION WITH PLUMBING CONTRACTOR.
- (2) 3/4" LP FOR COMBI OVENS (196 MBH INPUT TOTAL).
- ALL LP PIPING INDICATED TO BE ABOVE CEILING SHALL BE ROUTED IN JOIST SPACE.
- 1-1/2" LP DOWN IN WALL TO SERVE APPLIANCES. PROVIDE INDIVIDUAL STUB OUT FROM 1-1/2" HEADER FOR EACH APPLIANCE. SEE DETAIL 10H501.
- 1-1/2" LP DOWN THRU CEILING FOR KITCHEN EQUIPMENT. PROVIDE ELECTRONIC EMERGENCY SHUT OFF VALVE EXPOSED IN PREP AREA. COORDINATE PLACEMENT WITH KITCHEN EQUIPMENT.
- 3/4" LP FOR CHARBROILER (96 MBH INPUT).
- 1" LP FOR RANGE (278 MBH INPUT).
- (2) 3/4" LP FOR FRYERS (140 MBH INPUT TOTAL).
- ROUTE 2" LP DOWN INSIDE OF EXTERIOR WALL. STUB THRU EXTERIOR WALL ABOVE GRADE. AND CONNECT TO LP STUB BY OTHERS.
- ROUTE 2" LP DOWN WAREHOUSE WALL. ROUTE THRU WAREHOUSE WALL INTO OFFICE PLENUM.
- EXTERIOR LP TANK AND EXTERIOR PIPING DESIGN IS DELEGATED DESIGN AND IS NOT PART OF THESE DRAWINGS. COORDINATE CONNECTION WITH GENERAL CONTRACTOR. PROVIDE PRESSURE REGULATOR ABOVE GRADE TO REDUCE PRESSURE TO 14" W.C. TOTAL CONNECTED LOAD IS 938 MBH. APPROXIMATE EQUIVALENT LENGTH = 250 FT.
- ROUTE PIPING IN WAREHOUSE TIGHT TO UNDERSIDE OF JOISTS.
- ROUTE PIPING ABOVE WILL CALL BOX-IN-BOX COOLER.
- 3/4" LP FOR SALAMANDER (30 MBH INPUT).

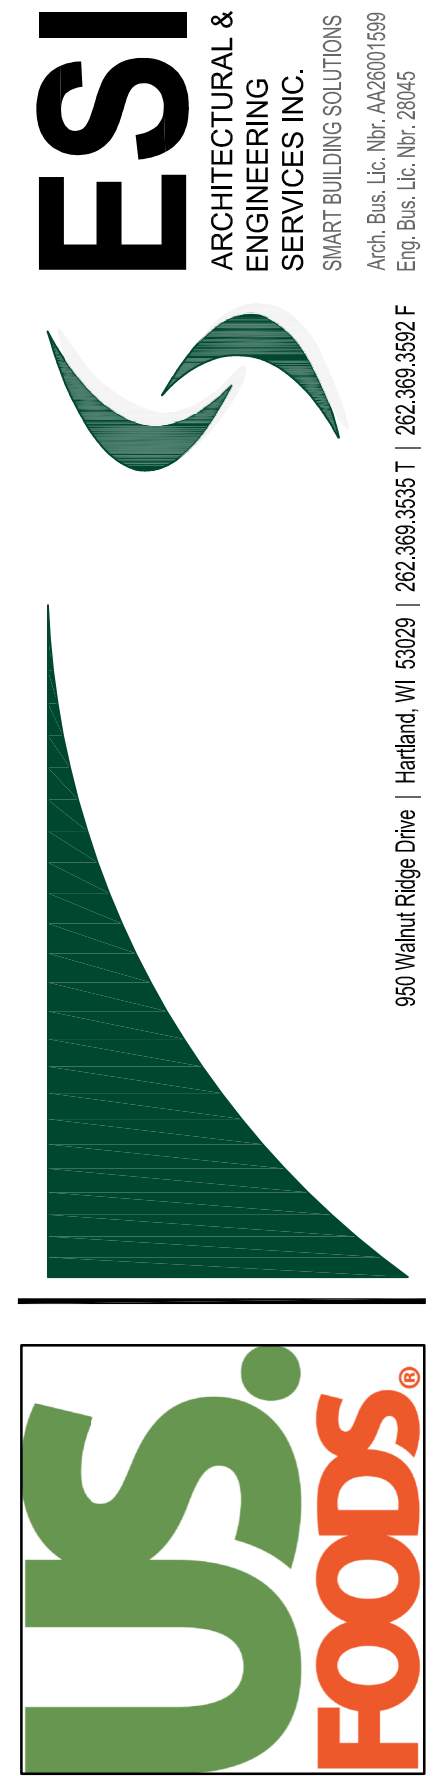

KITCHEN RENOVATION FOR
US FOODS - SOUTH FLORIDA
7598 NW 6TH AVENUE
BOCA RATON, FL 33487

REVISIONS

NO.	DATE	DESCRIPTION
1	2/7/2020	ADDENDUM #1
2		
3		
4		
5		
6		
7		
8		
9		
10		
11		
12		
13		
14		

DATE	JOB NO.
1-6-20	50-1414-19
DWG BY	CHKD BY
AMK	JRO

SHEET TITLE

HVAC
PIPING PLAN

PRELIMINARY DWGS.	
FINAL CONST. DWGS.	

SHEET NUMBER

H202

HVAC