

- GENERAL NOTES
1.

SEE APPLICABLE NOTES ON SHEET E001.
2.

ALL EMERGENCY LIGHTING AND EXIT LIGHTS ARE CIRCUITED TO EH6-13.
4.



FOR ALL EMERGENCY LIGHT FIXTURES, PROVIDE (1) WATTSTOPPER ELCU-200 PER ROOM TO ALLOW LOCAL LIGHTING CONTROL DEVICES TO CONTROL EMERGENCY LIGHT FIXTURE(S) WHEN NORMAL POWER IS PRESENT. EMERGENCY LIGHT FIXTURES SHALL COME ON WHEN NORMAL POWER IS LOST.
5.

SEE SHEET E802 FOR LIGHTING CONTROL MATRIX AND SEQUENCE OF OPERATION.

- KEY NOTES - THIS SHEET ONLY
1.

DAYLIGHT ZONE IS LESS THAN 150W AND THEREFORE NOT REQUIRED.
2.

ALL PANELS IN ROOM B108 ARE EXISTING.

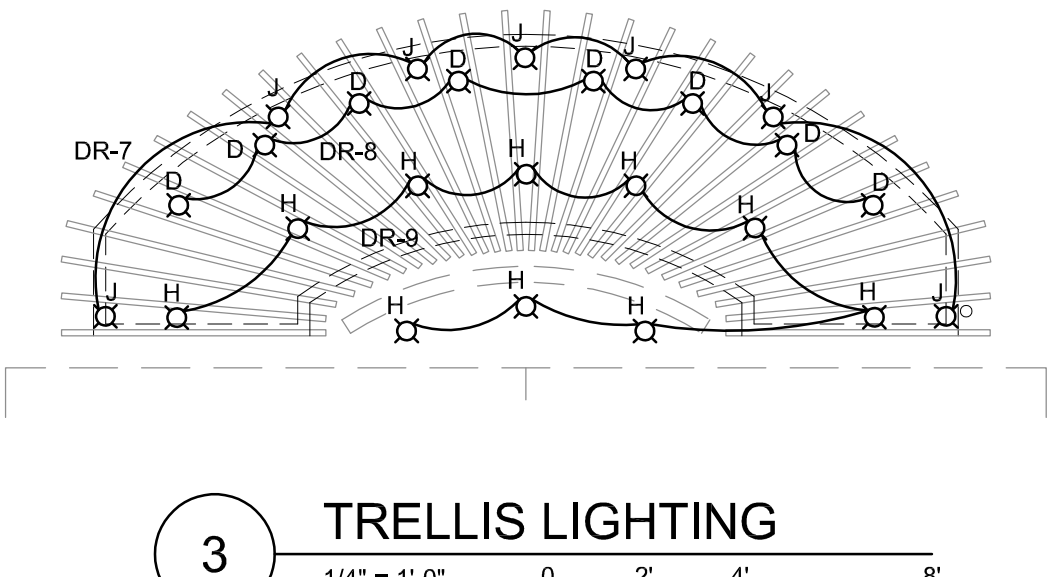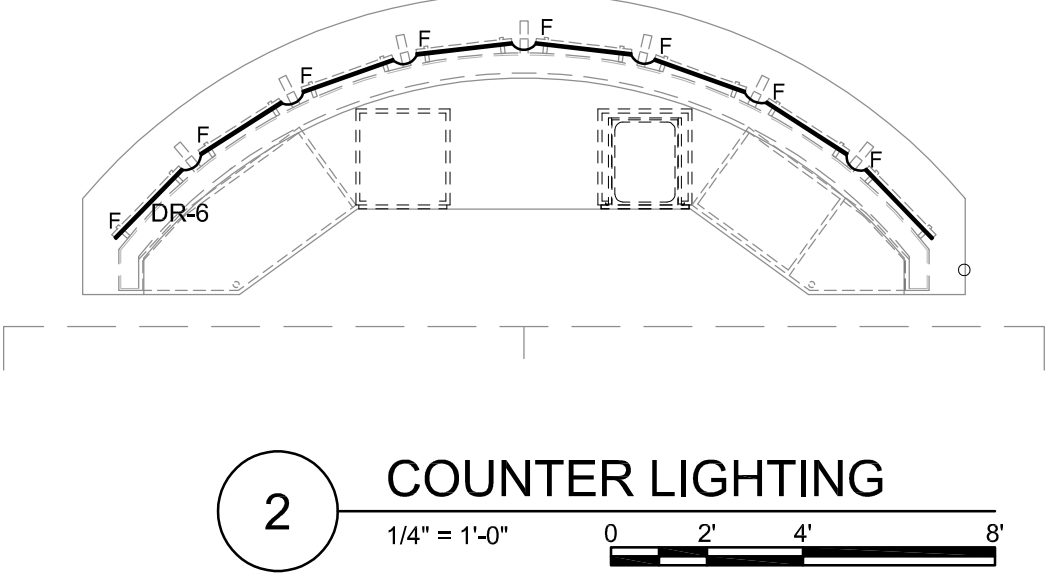

1

LIGHTING PLAN

3/16" = 1'-0"

0 4' 8' 12'

KEY PLAN

NOT TO SCALE

REVISIONS	
△	-
△	-
DATE	JOB NO.
1-6-20	50-1414-19
DWG BY	CHKD BY
EGP	TJM

SHEET TITLE

LIGHTING PLAN

PRELIMINARY DWGS.	
FINAL CONST. DWGS.	
SHEET NUMBER	