


P:\Draws\2019\161 06089_Winterhaven Apartments\05 Electrical\06089_Electrical.rvt
5/3/2019 3:58:42 PM

PAVILLION FLOOR PLAN - LIGHTING

SCALE: 1/4" = 1'-0"

1

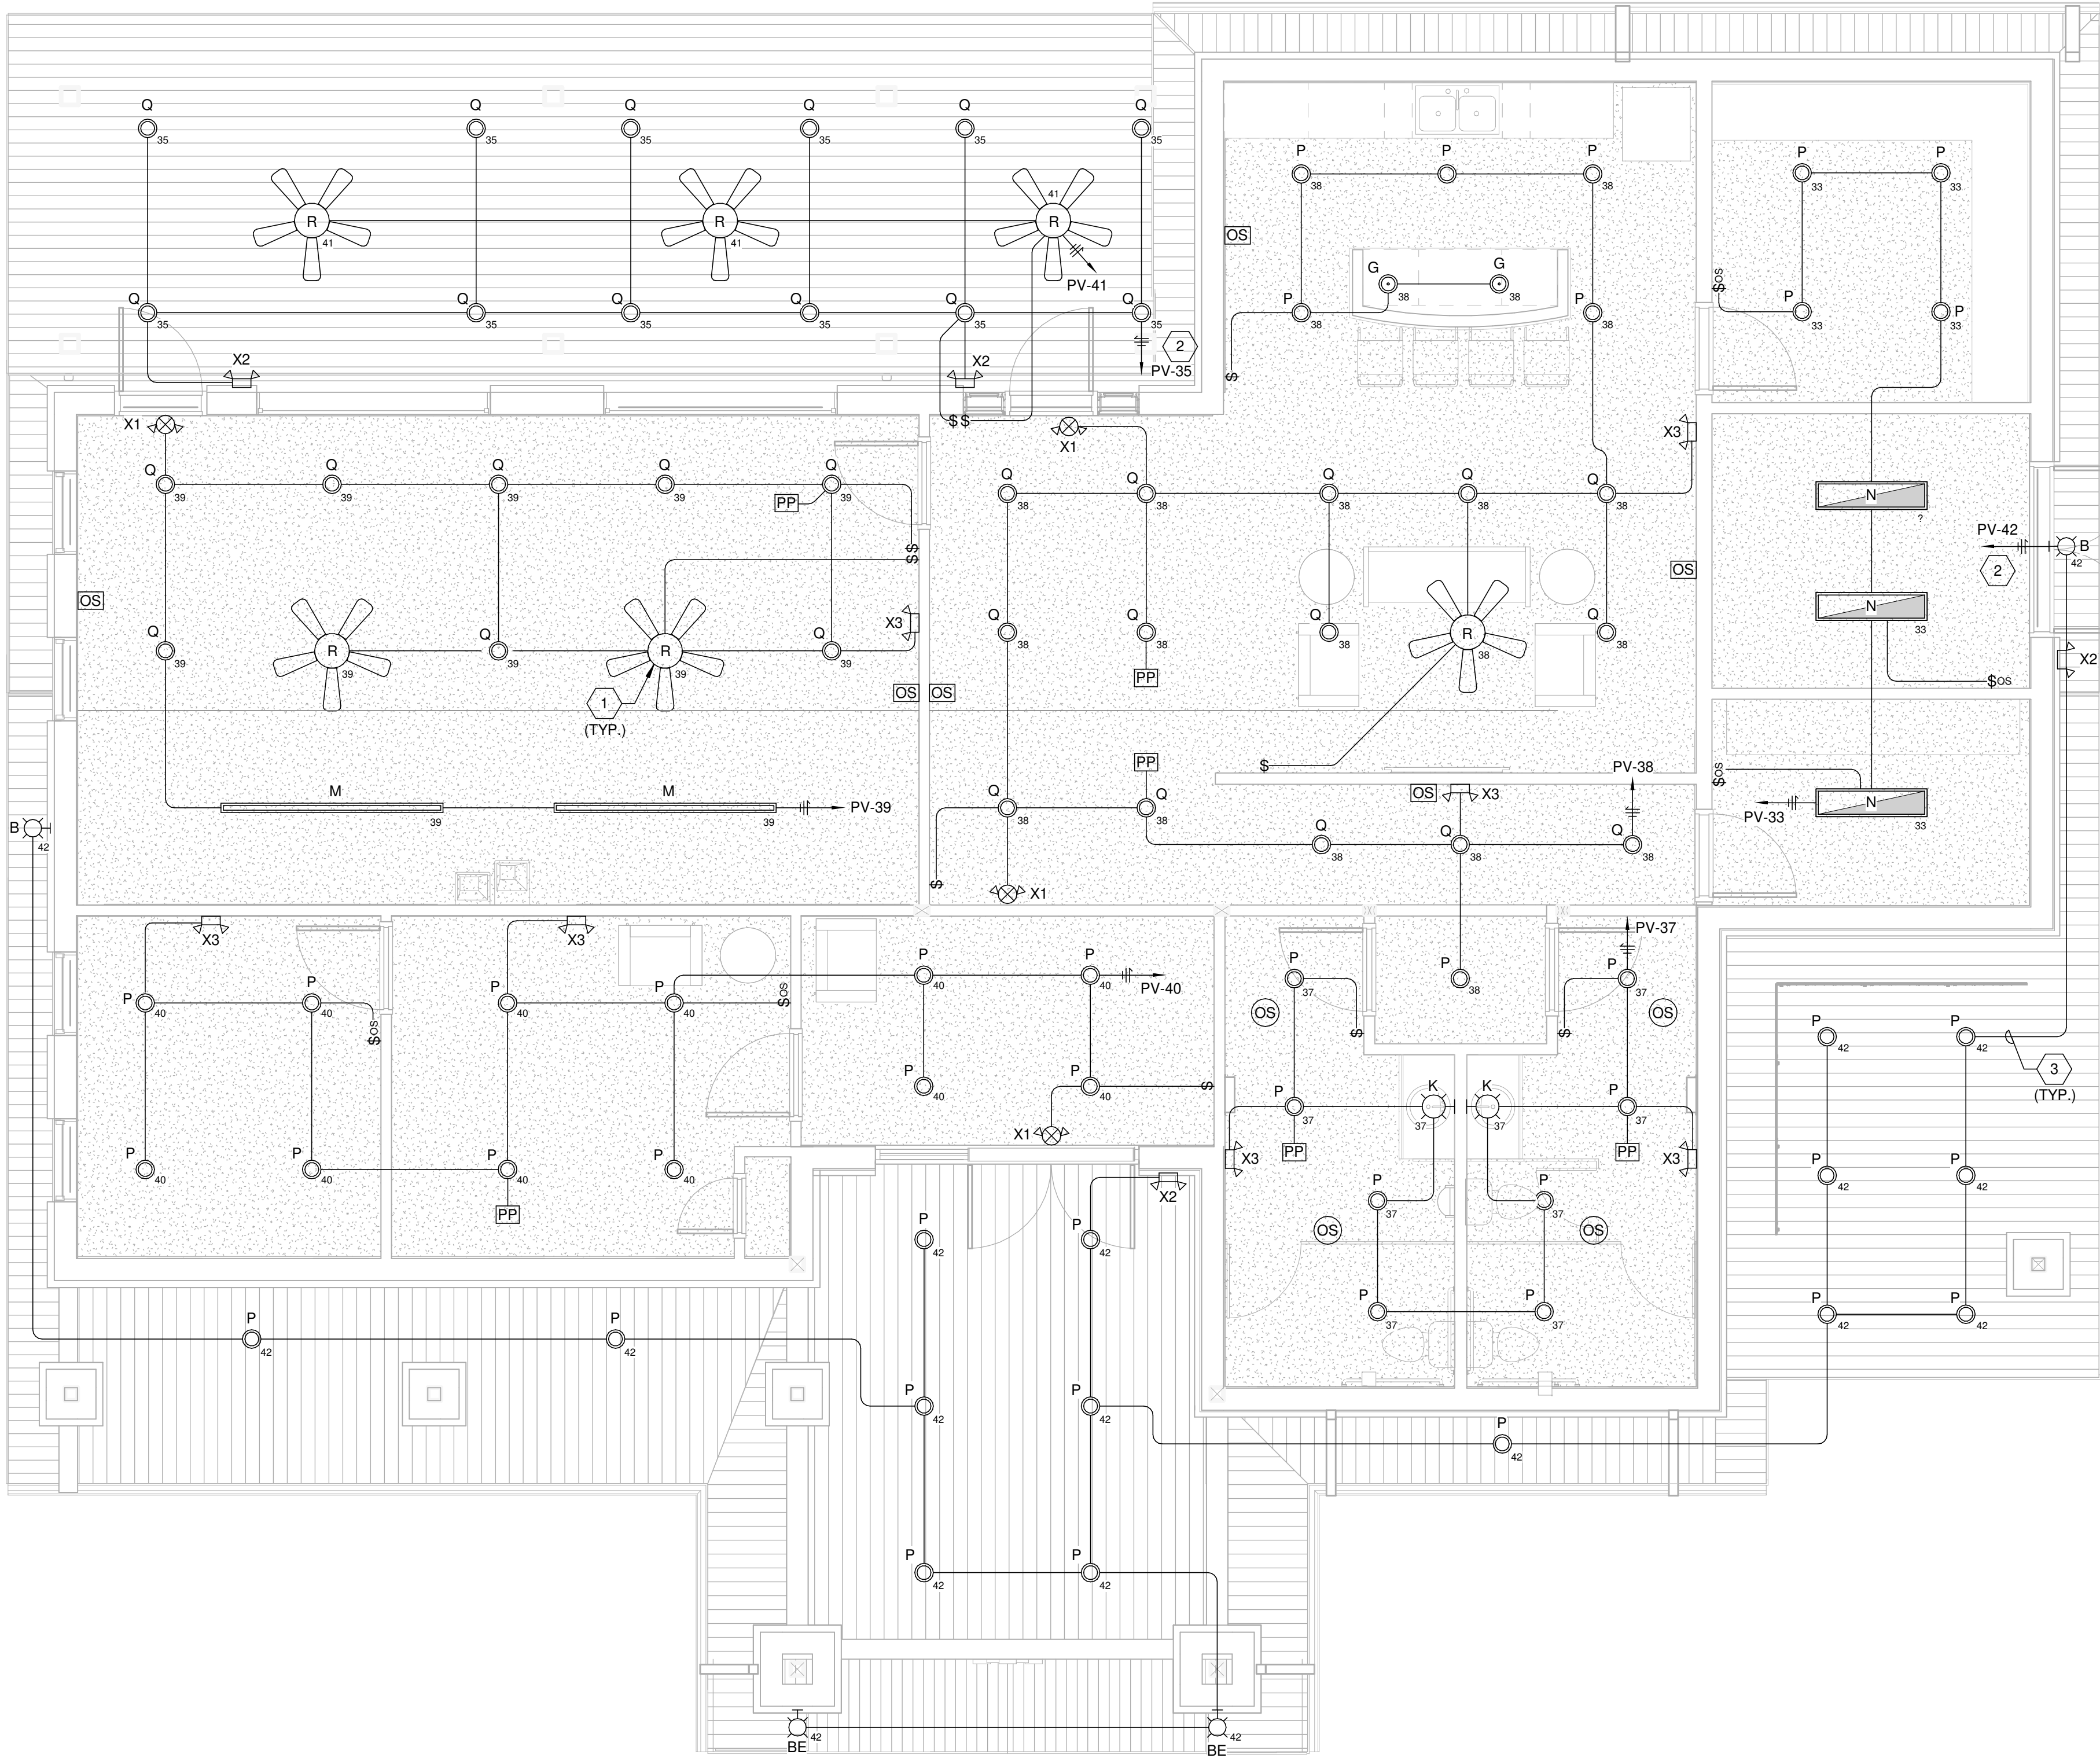


GENERAL SHEET NOTES

1. SEE SHEET E001 FOR ELECTRICAL LEGEND AND GENERAL NOTES.

KEYED SHEET NOTES

1. PROVIDE ADEQUATE BRACING AND BACK BOX APPROVED FOR FAN/CHANDELIER USE. PROVIDE TWO SWITCHES FOR FAN/LIGHT COMBO. ONE SWITCH FOR FAN AND ONE SWITCH FOR LIGHT.
2. CIRCUIT CONTROLLED VIA THE LIGHTING CONTROL PANEL "LCPCH". SEE LIGHTING CONTROL PANEL DETAIL ON SHEET E501 FOR ADDITIONAL INFORMATION.
3. CONDUIT SHOWN ON THE OUTSIDE OF THE BUILDING FOR CLARITY PURPOSES ONLY. RUN ALL CONDUIT CONCEALED ON THE INSIDE OF THE BUILDING.

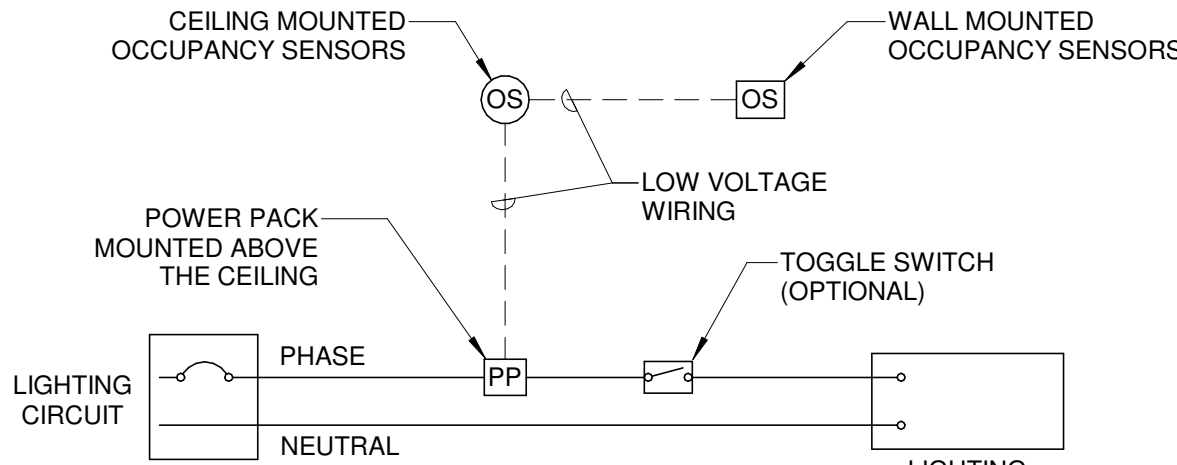

DETAIL INDICATES HOW LIGHTING MAY BE TURNED "OFF" BY A MANUAL TOGGLE SWITCH. WHEN SWITCH IS "ON" LIGHTING WILL AUTOMATICALLY TURN "OFF" IN LESS THEN 30 MINUTES IF SPACE IS UNOCCUPIED.

OCCUPANCY SENSOR DETAIL

SCALE: 12" = 1'-0"

3


MBI

MBI COMPANIES INC.
299 N. WEISGARBER ROAD
KNOXVILLE, TN 37919
PHONE: (865) 584-0999
FAX: (865) 584-5213
WEB: mbicompanies.com

ELECTRICAL ENGINEER:
CHARLES H. POWELL JR.

MBI COMPANIES INC.
299 N. WEISGARBER RD
KNOXVILLE, TN 37919
PHONE: (865) 584-0999
FAX: (865) 584-5213
WEB: mbicompanies.com

SEAL

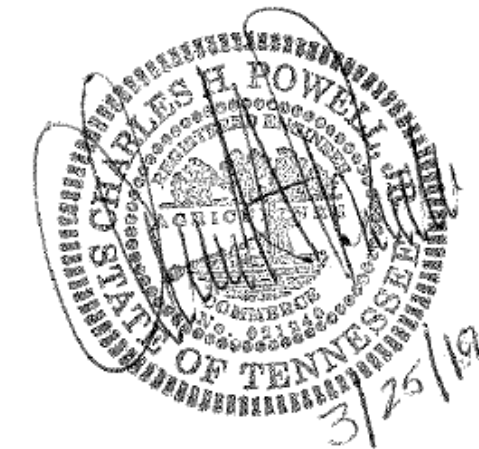

COPYRIGHT © MBI COMPANIES INC. 2019
THE DESIGN PROFESSIONAL DENIES ANY AND ALL RESPONSIBILITY AND LIABILITY FOR PROBLEMS WHICH ARISE FROM FAILURE TO FOLLOW THESE PLANS, SPECIFICATIONS AND THE DESIGN INTENT THEY CONVEY, OR PROBLEMS WHICH ARISE FROM OTHERS' FAILURE TO OBTAIN AND/OR FOLLOW THE DESIGN PROFESSIONAL'S GUIDANCE WITH RESPECT TO ANY ERRORS, OMISSIONS, INCONSISTENCIES, AMBIGUITIES OR CONFLICTS WHICH ARE ALLEGED.

PROJECT INFORMATION

PROJECT:

WESTWOOD AT
WINTER HAVEN

PROJECT ADDRESS:

xxxx Avenue G
Winter Haven, FL 36901

PROJECT NO.: 180888

ACTIVE DESIGN PHASE

- ☐ FOR REVIEW ONLY
☐ FOR PERMITTING ONLY
☐ SCHEMATIC DESIGN
☐ DESIGN DEVELOPMENT
☐ CONSTRUCTION BIDDING
☒ CONSTRUCTION DOCUMENTS
☐ AS-BUILT RECORD SET

REVISION INFORMATION

NO. DATE DESCRIPTION

KEY PLAN

SHEET INFORMATION

SHEET ISSUED: 3-25-19
DESIGNED BY: WAH
DRAWN BY: WAH
REVIEWED BY: CHP
SHEET TITLE:

PAVILLION PLAN -
LIGHTING

SHEET NO.:

E203